


BENCHMARK IN POWER POLE
WAS TRANSFERRED FROM TOP
OF CASING ELEVATION IN MW-5
OF 197.76

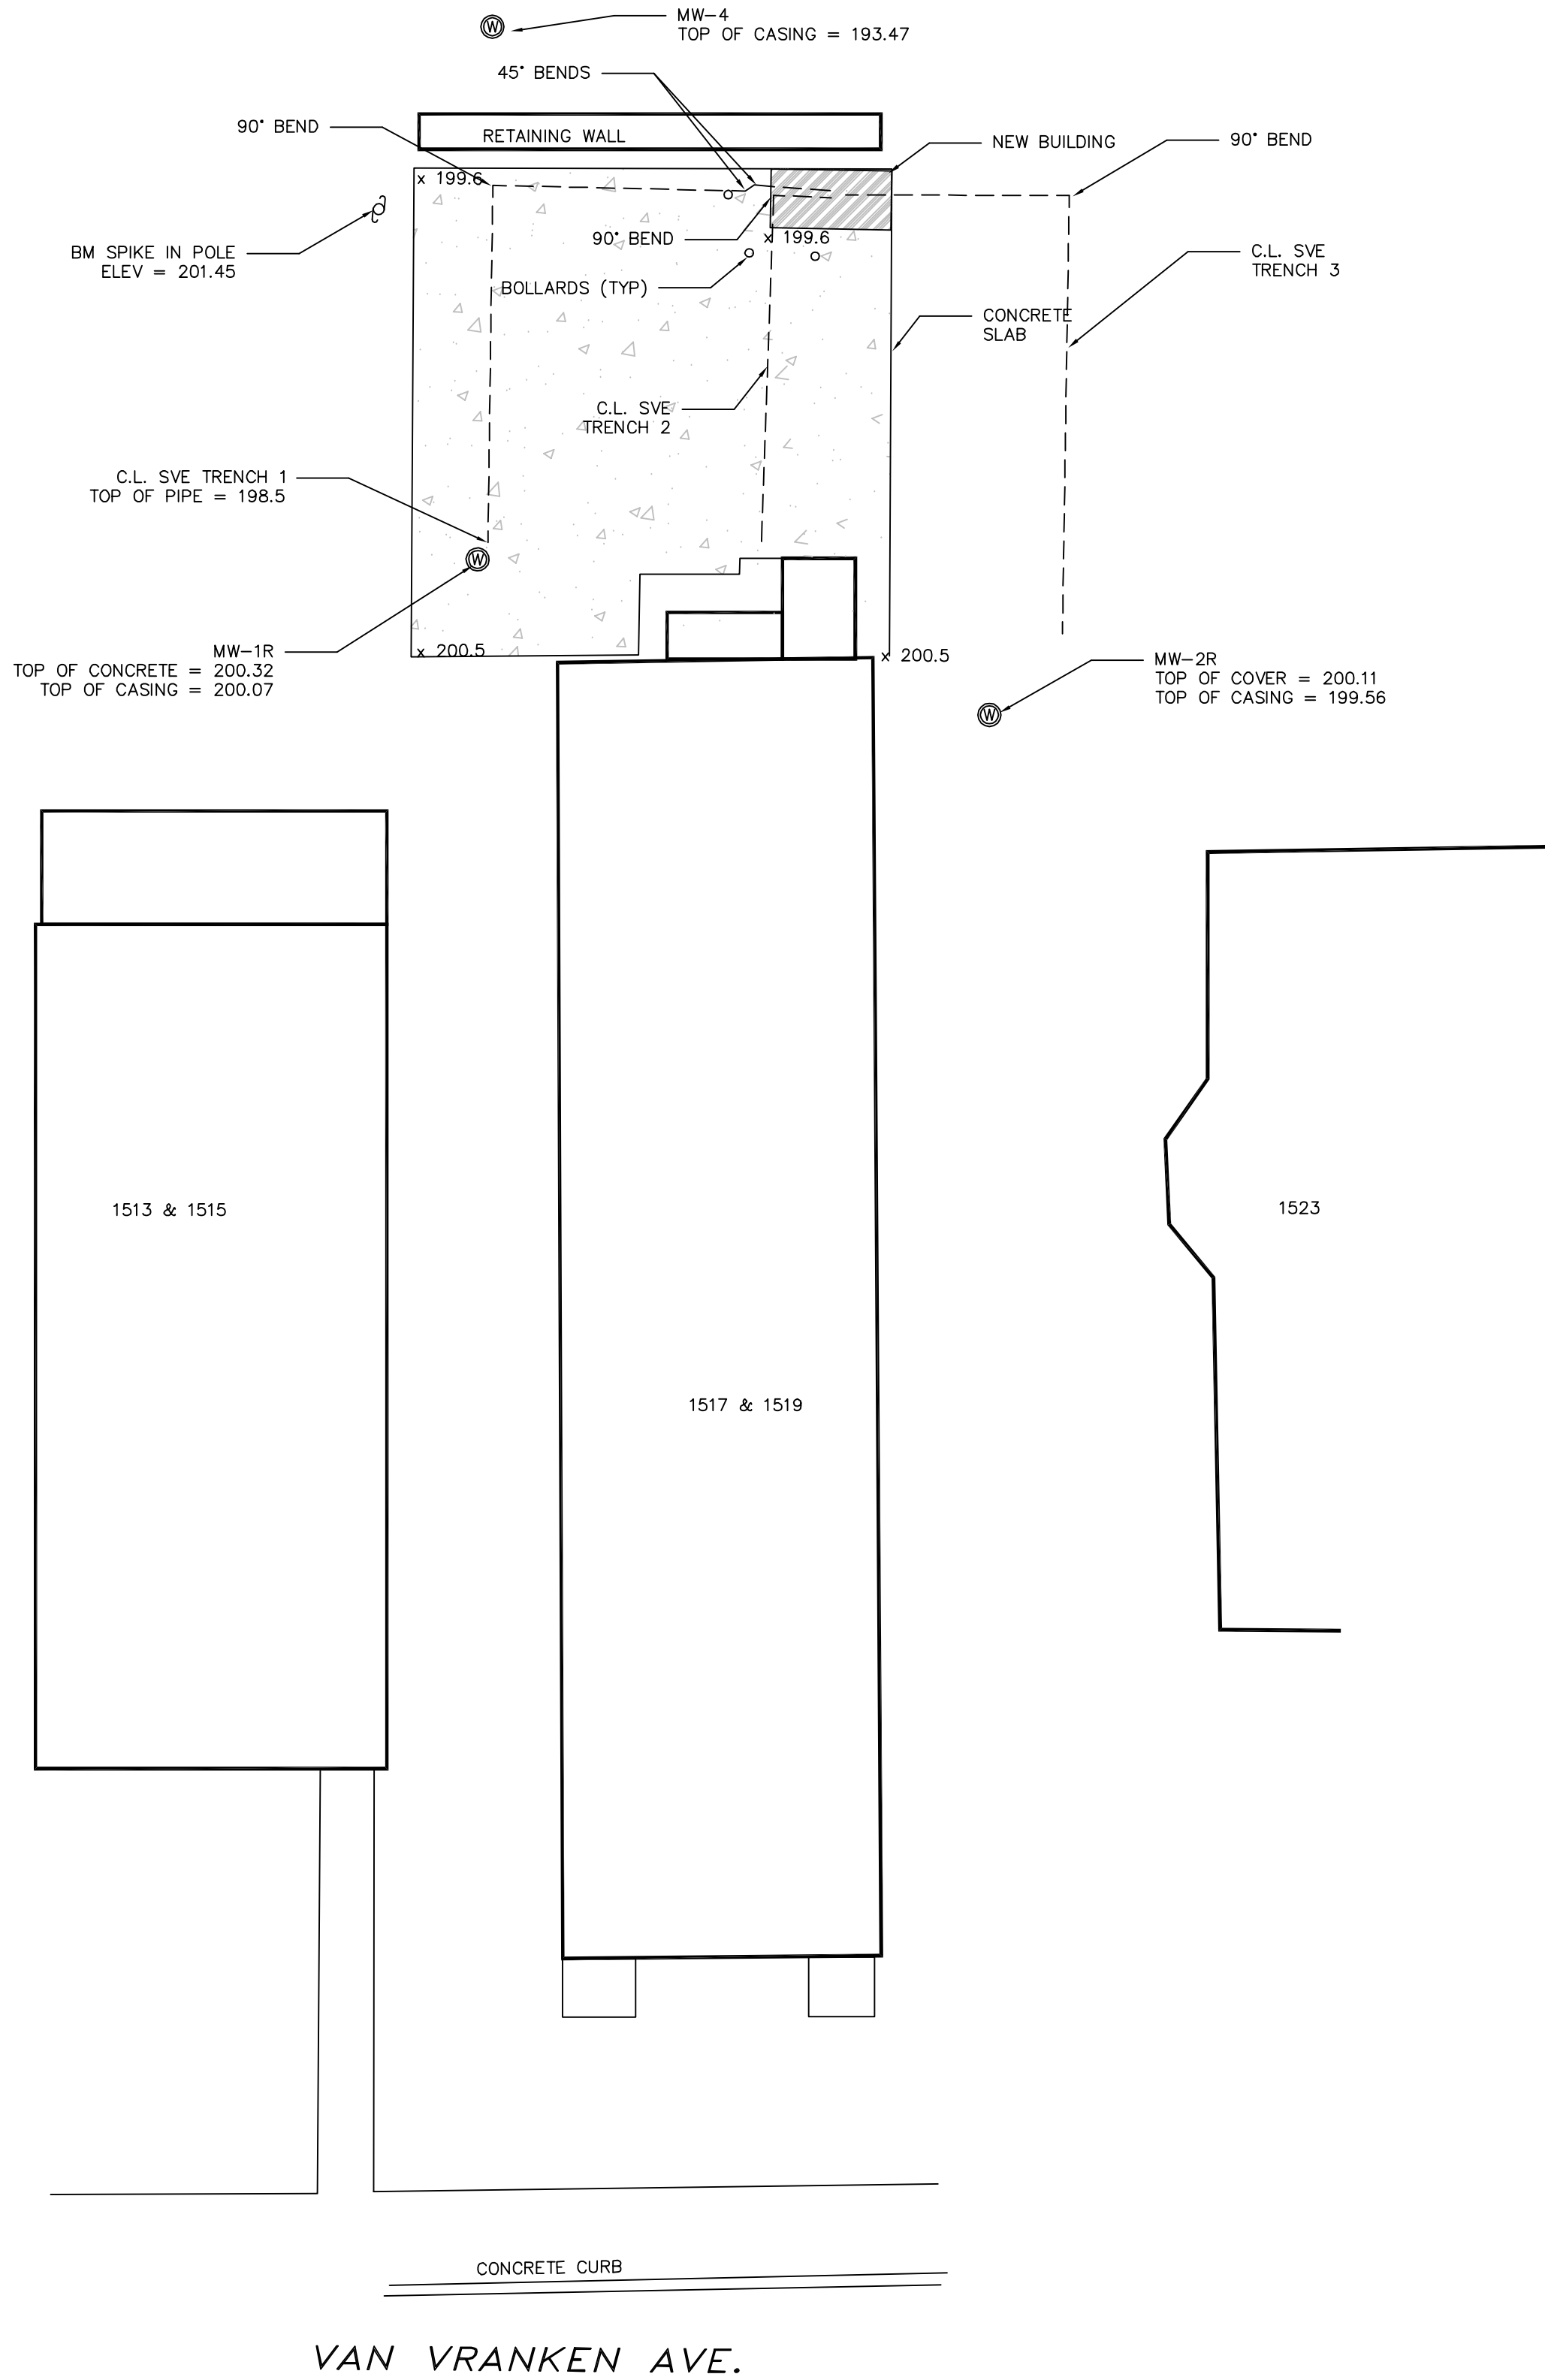

VAN VRANKEN AVE.

RECORD PLANS


SITE PLAN

DAMBROSE CLEANERS

CITY OF SCHENECTADY SCHENECTADY COUNTY, NEW YORK

DRAWN	JAD	DATE	7/1/10	REVISION DATE
SCALE	1" = 10'	JOB NO.	JOB	FILE NAME

DRAWING NO.	1
REV. NO.	
SHEET	1
OF	1



GREYSTONE ENGINEERING
4 Franklin Square
Saratoga Springs, NY 12866

Copyright © 2010 by Greystone Engineering. This drawing is an instrument of service and is the property of Myers Engineering. This drawing may not be reproduced in whole or in part by any means whatsoever without the expressed written consent of Greystone Engineering.

CHECKED	
DESIGN ENGINEER	
PROJECT ENGINEER	D. A. M.
PROJECT MANAGER	
APPROVED	
APPROVED	

UNAUTHORIZED ALTERATION OR ADDITION TO THIS DRAWING IS A VIOLATION
OF SECTION 7209, SUBDIVISION 2 OF THE NEW YORK STATE EDUCATION LAW