


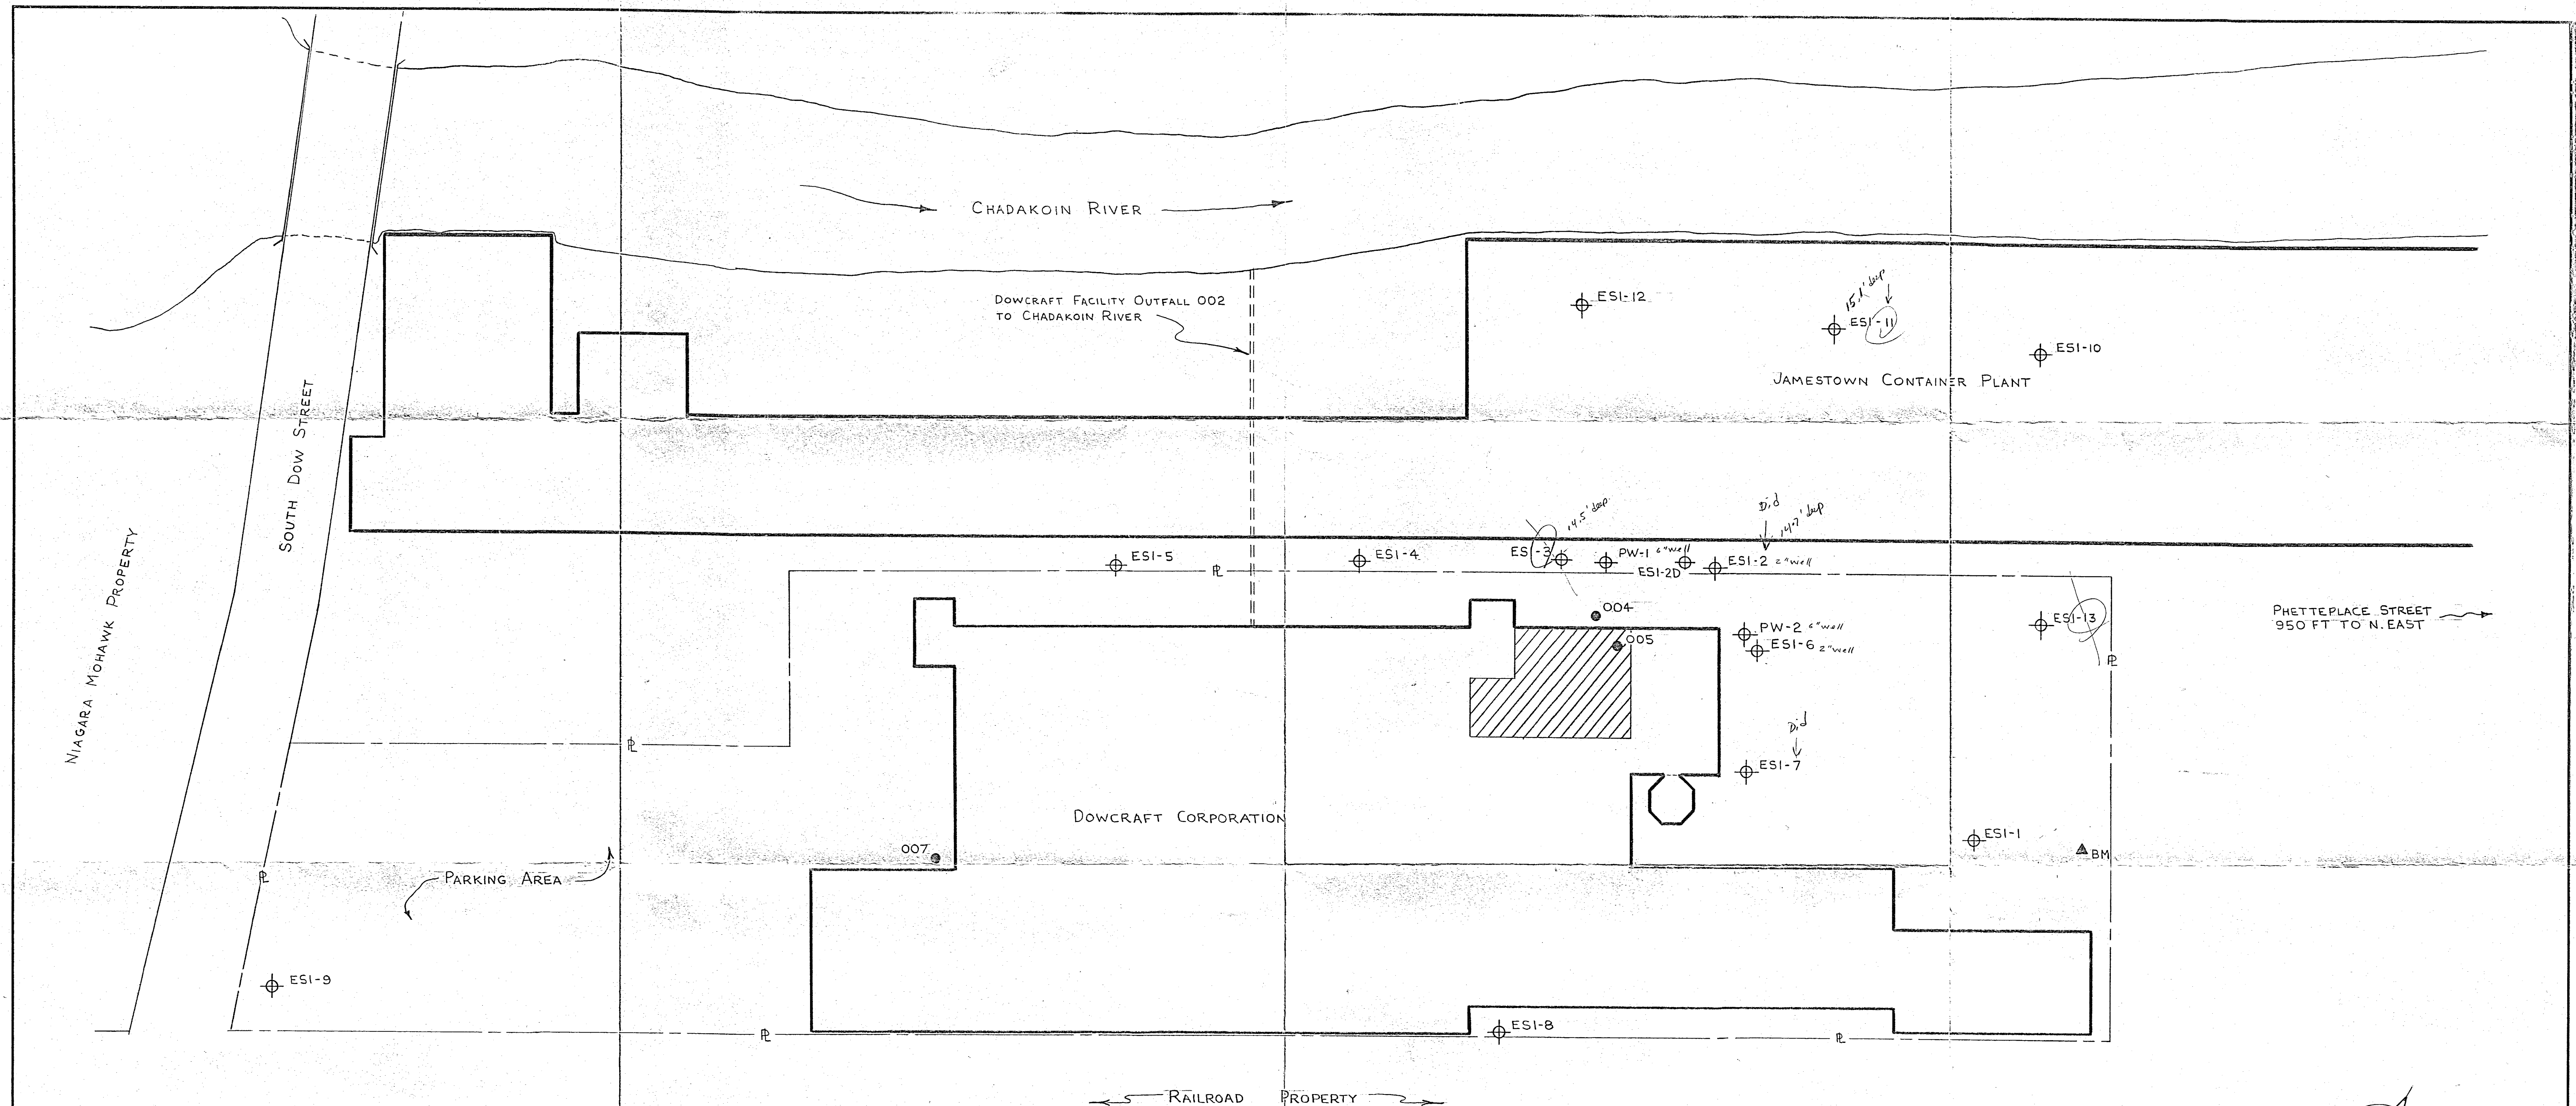

LEGEND:

- ⊕ GROUNDWATER MONITORING WELL LOCATION
- DRYWELL LOCATION
- ▲_{BM} BENCHMARK LOCATION
-  AREA USED FOR TRICHLOROETHENE AND SPENT TRICHLOROETHENE STORAGE DURING THE PERIOD BETWEEN 1948 TO 1978.

NOTES:

- THIS DRAWING IS FOR ILLUSTRATIVE PURPOSES ONLY.
- THIS DRAWING WAS ADAPTED FROM A SITE PLAN SUPPLIED BY DOWCRAFT CORPORATION, DATED 3-27-84.




SITE PLAN

SCALE: 1" = 25'	APPROVED BY: KJS	DRAWN BY: DAW
DATE: 4-93		REVISED

DOWCRAFT CORPORATION

65 SOUTH DOW STREET
FALCONER, N.Y. 14733

DRAWING NUMBER
2

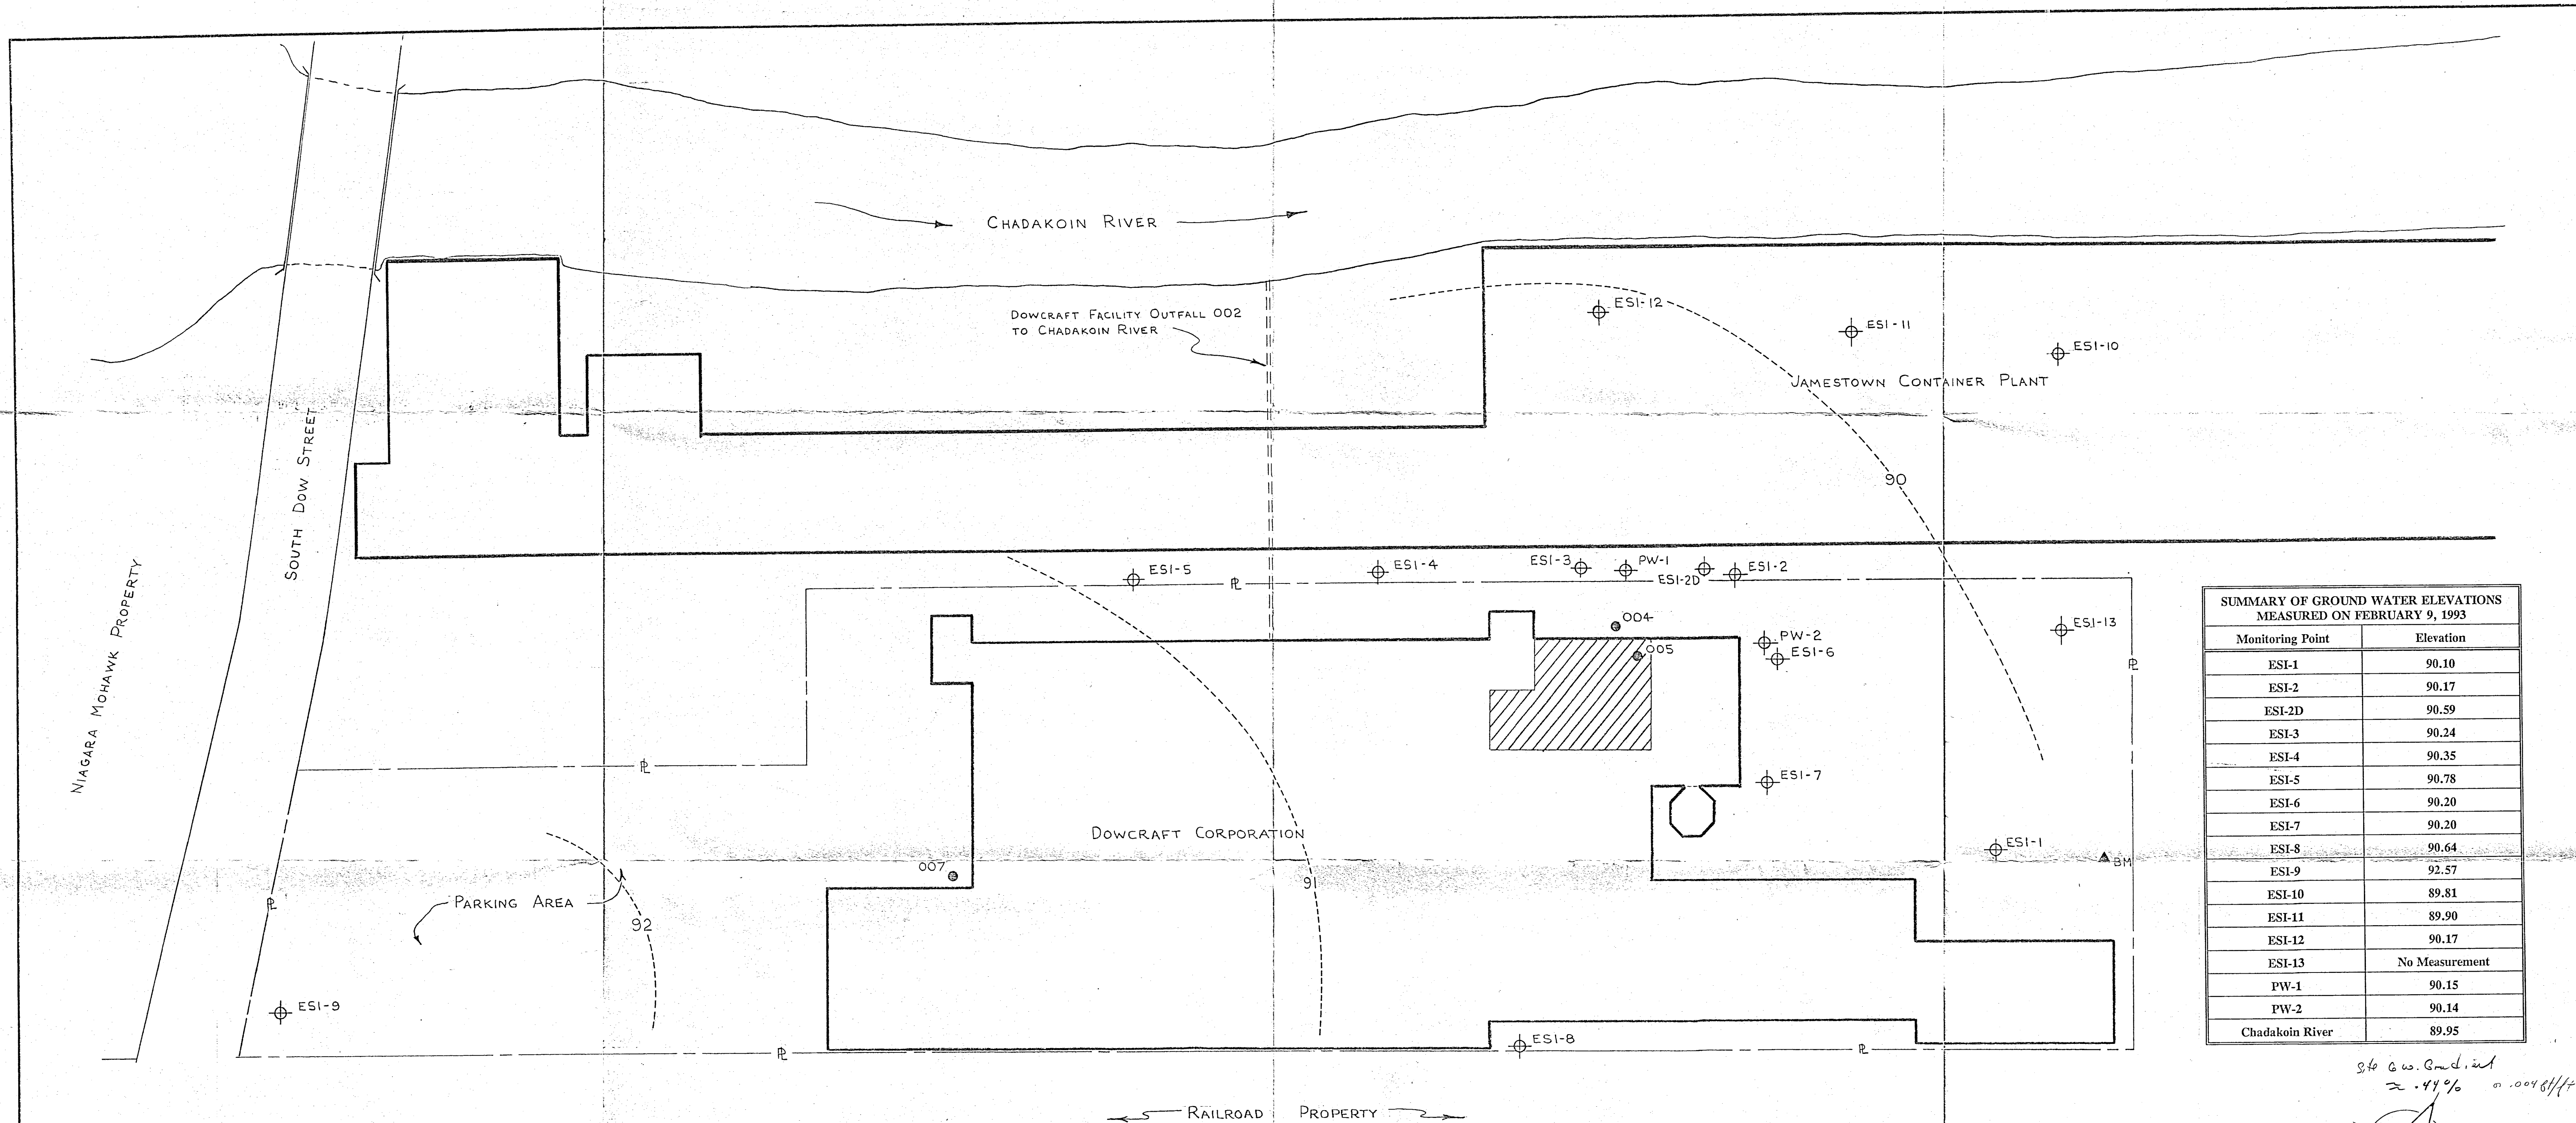

SUMMARY OF GROUND WATER ELEVATIONS MEASURED ON FEBRUARY 9, 1993	
Monitoring Point	Elevation
ESI-1	90.10
ESI-2	90.17
ESI-2D	90.59
ESI-3	90.24
ESI-4	90.35
ESI-5	90.78
ESI-6	90.20
ESI-7	90.20
ESI-8	90.64
ESI-9	92.57
ESI-10	89.81
ESI-11	89.90
ESI-12	90.17
ESI-13	No Measurement
PW-1	90.15
PW-2	90.14
Chadakoin River	89.95

Site G.W. Contour
 ~ .44% on 0048/17
 NORTH

LEGEND:

- ⊕ GROUNDWATER MONITORING WELL LOCATION
- DRYWELL LOCATION
- ▲_{BM} BENCHMARK LOCATION

AREA USED FOR TRICHLOROETHENE AND SPENT TRICHLOROETHENE STORAGE DURING THE PERIOD BETWEEN 1948 TO 1978.

----- GROUND WATER ELEVATION CONTOUR LINE

NOTES:


- THIS DRAWING IS FOR ILLUSTRATIVE PURPOSES ONLY
- THIS DRAWING WAS ADAPTED FROM A SITE PLAN SUPPLIED BY DOWCRAFT CORPORATION, DATED 3-27-84
- GROUND WATER ELEVATIONS ARE RELATIVE TO A BENCH MARK (▲_{BM}) SET AT AN ARBITRARY ELEVATION OF 100 FEET. BENCH MARK IS TOP OF NUT ON WEST SIDE OF FLANGE ON FIRE HYDRANT, NORTH OF EAST END OF BUILDING
- GROUND WATER LEVELS WERE MEASURED ON FEB 9, 1993



GROUND WATER ELEVATION CONTOUR MAP
 (FEBRUARY 9, 1993)

SCALE: 1" = 25' APPROVED BY: KJS DRAWN BY: DAW
 DATE: 4-93 REVISED:


DOWCRAFT CORPORATION
 65 SOUTH DOW STREET
 FALCONER, N.Y. 14733
 DRAWING NUMBER: 4

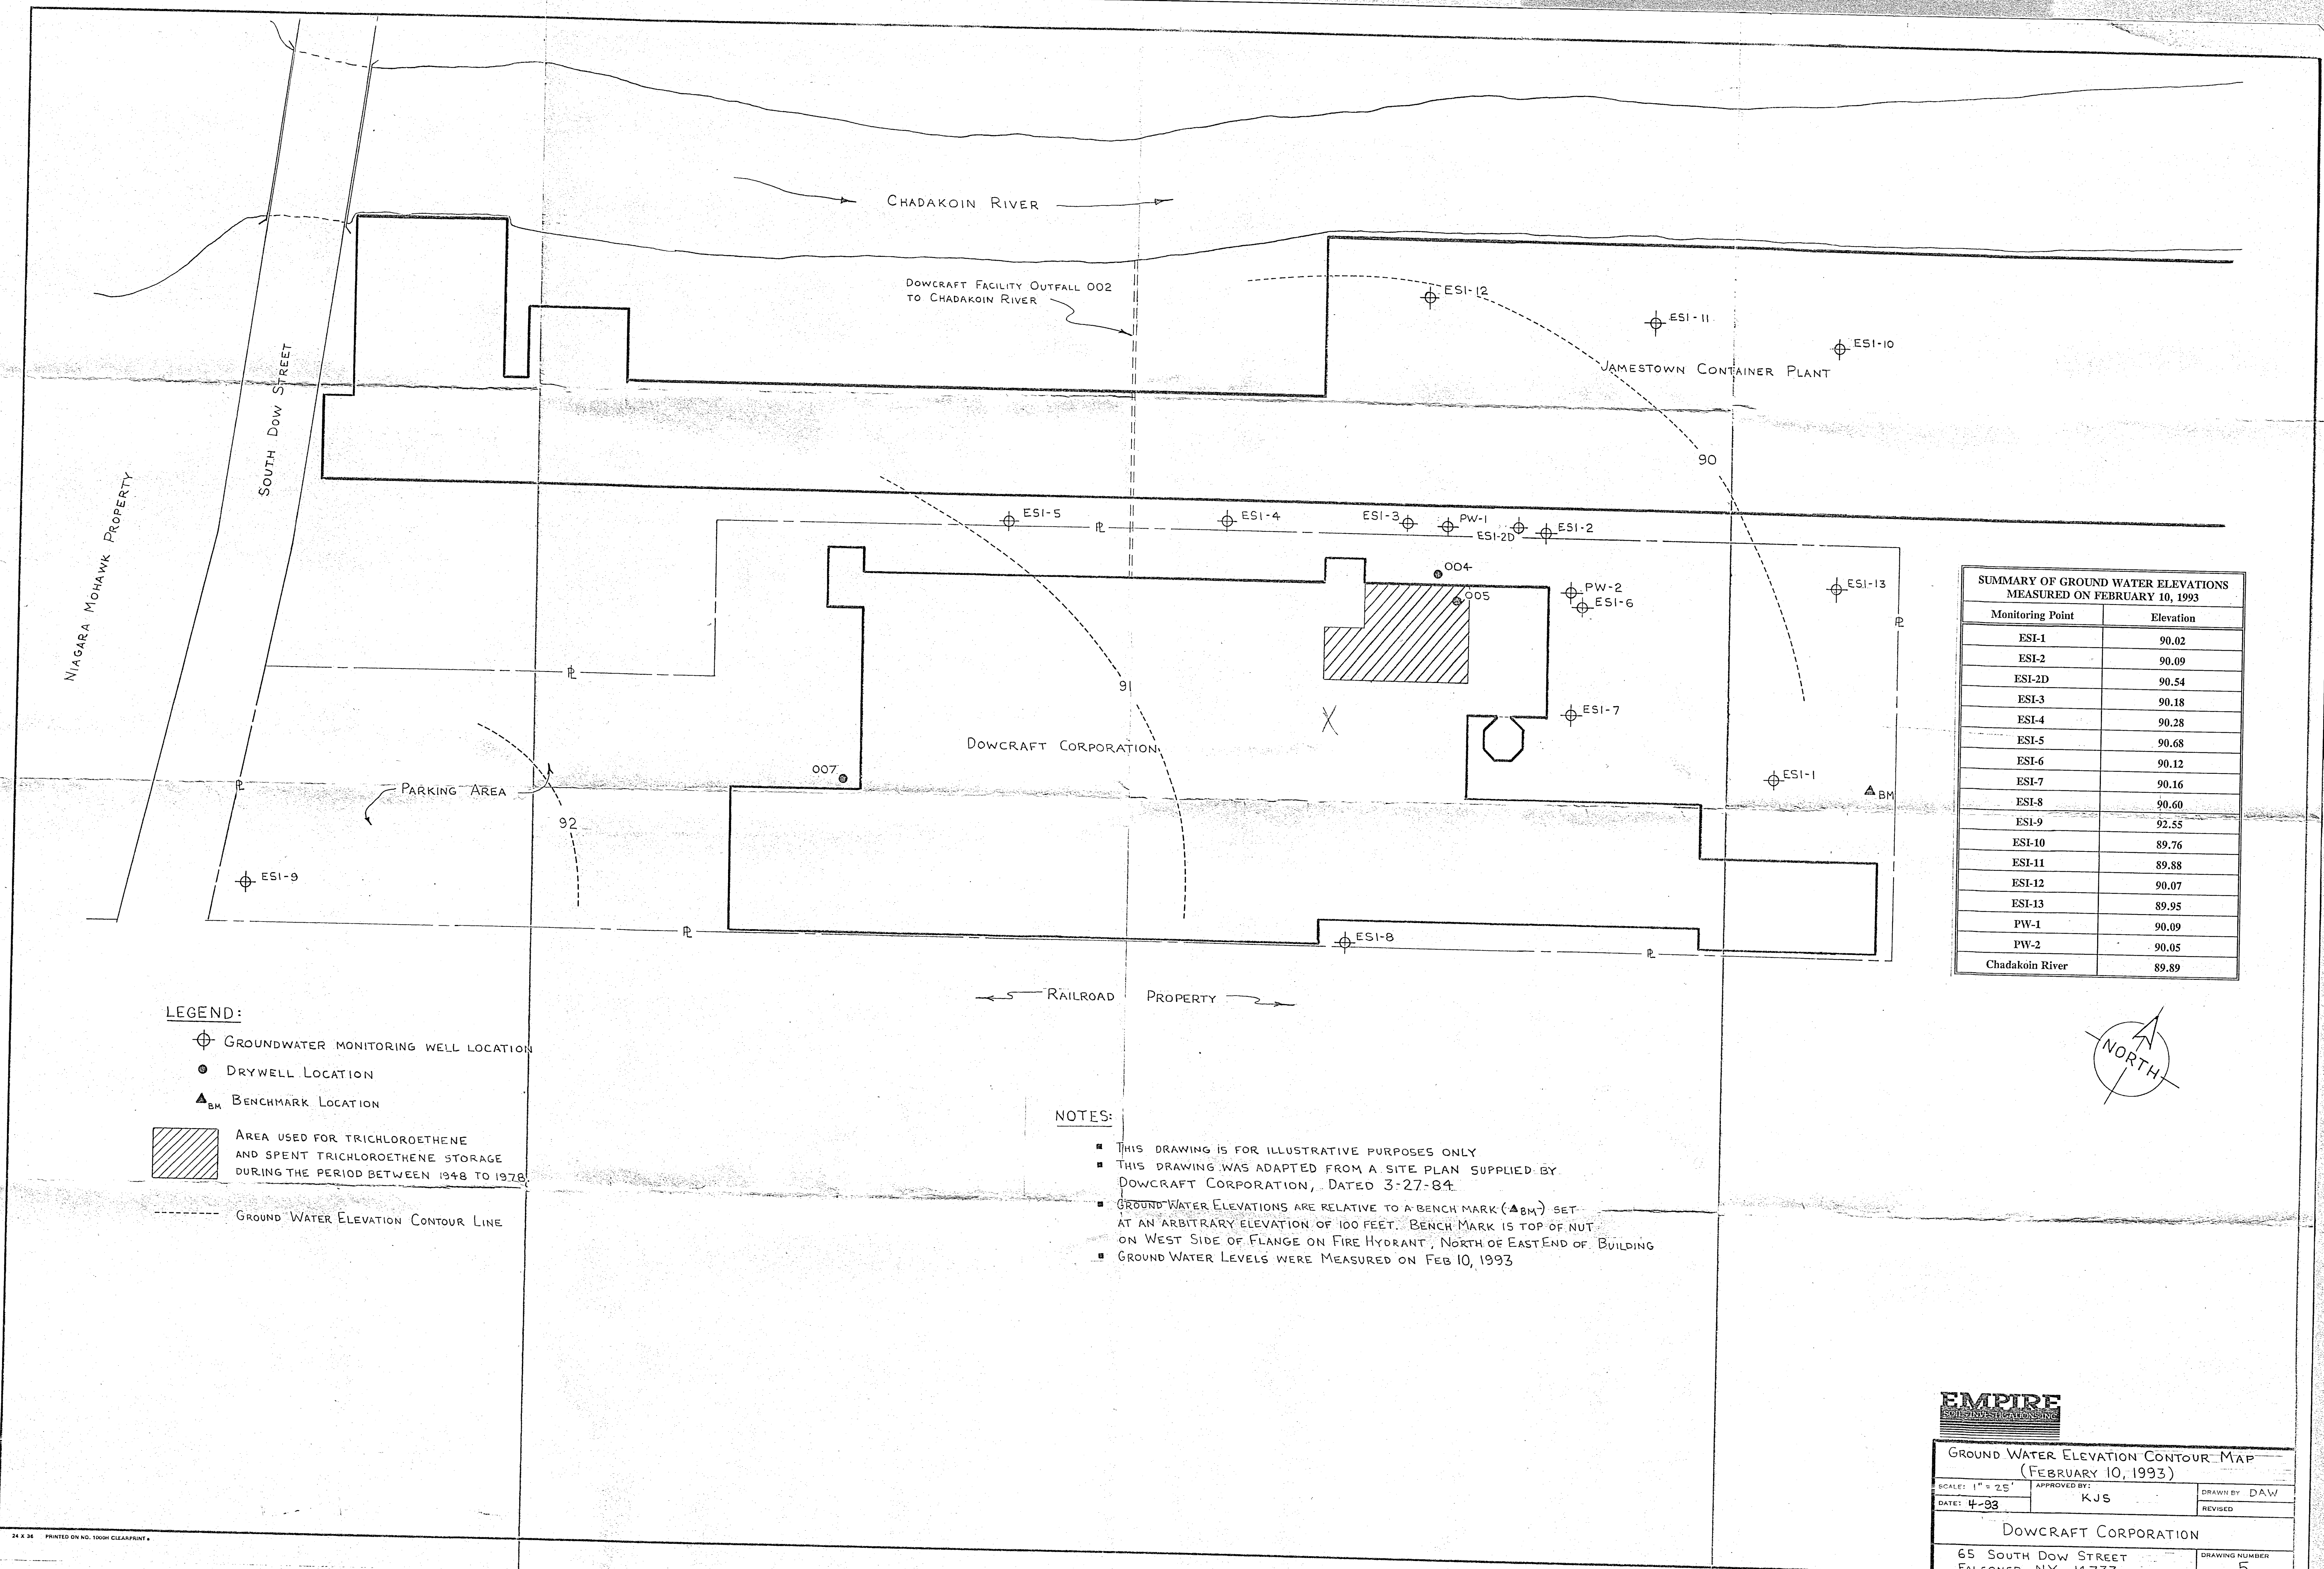

SUMMARY OF GROUND WATER ELEVATIONS MEASURED ON FEBRUARY 10, 1993	
Monitoring Point	Elevation
ESI-1	90.02
ESI-2	90.09
ESI-2D	90.54
ESI-3	90.18
ESI-4	90.28
ESI-5	90.68
ESI-6	90.12
ESI-7	90.16
ESI-8	90.60
ESI-9	92.55
ESI-10	89.76
ESI-11	89.88
ESI-12	90.07
ESI-13	89.95
PW-1	90.09
PW-2	90.05
Chadakoïn River	89.89

LEGEND:

- ⊕ GROUNDWATER MONITORING WELL LOCATION
- DRYWELL LOCATION
- ▲_{BM} BENCHMARK LOCATION

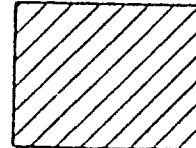 AREA USED FOR TRICHLOROETHENE AND SPENT TRICHLOROETHENE STORAGE DURING THE PERIOD BETWEEN 1948 TO 1978


----- GROUND WATER ELEVATION CONTOUR LINE

NOTES:

- THIS DRAWING IS FOR ILLUSTRATIVE PURPOSES ONLY
- THIS DRAWING WAS ADAPTED FROM A SITE PLAN SUPPLIED BY DOWCRAFT CORPORATION, DATED 3-27-84.
- GROUND WATER ELEVATIONS ARE RELATIVE TO A BENCH MARK (▲_{BM}) SET AT AN ARBITRARY ELEVATION OF 100 FEET. BENCH MARK IS TOP OF NUT ON WEST SIDE OF FLANGE ON FIRE HYDRANT, NORTH OF EAST END OF BUILDING
- GROUND WATER LEVELS WERE MEASURED ON FEB 10, 1993



GROUND WATER ELEVATION CONTOUR MAP (FEBRUARY 10, 1993)		
SCALE: 1" = 25'	APPROVED BY: KJS	DRAWN BY: DAW
DATE: 4-93	REVISED	
DOWCRAFT CORPORATION		
65 SOUTH DOW STREET FALCONER, N.Y. 14733		DRAWING NUMBER 5

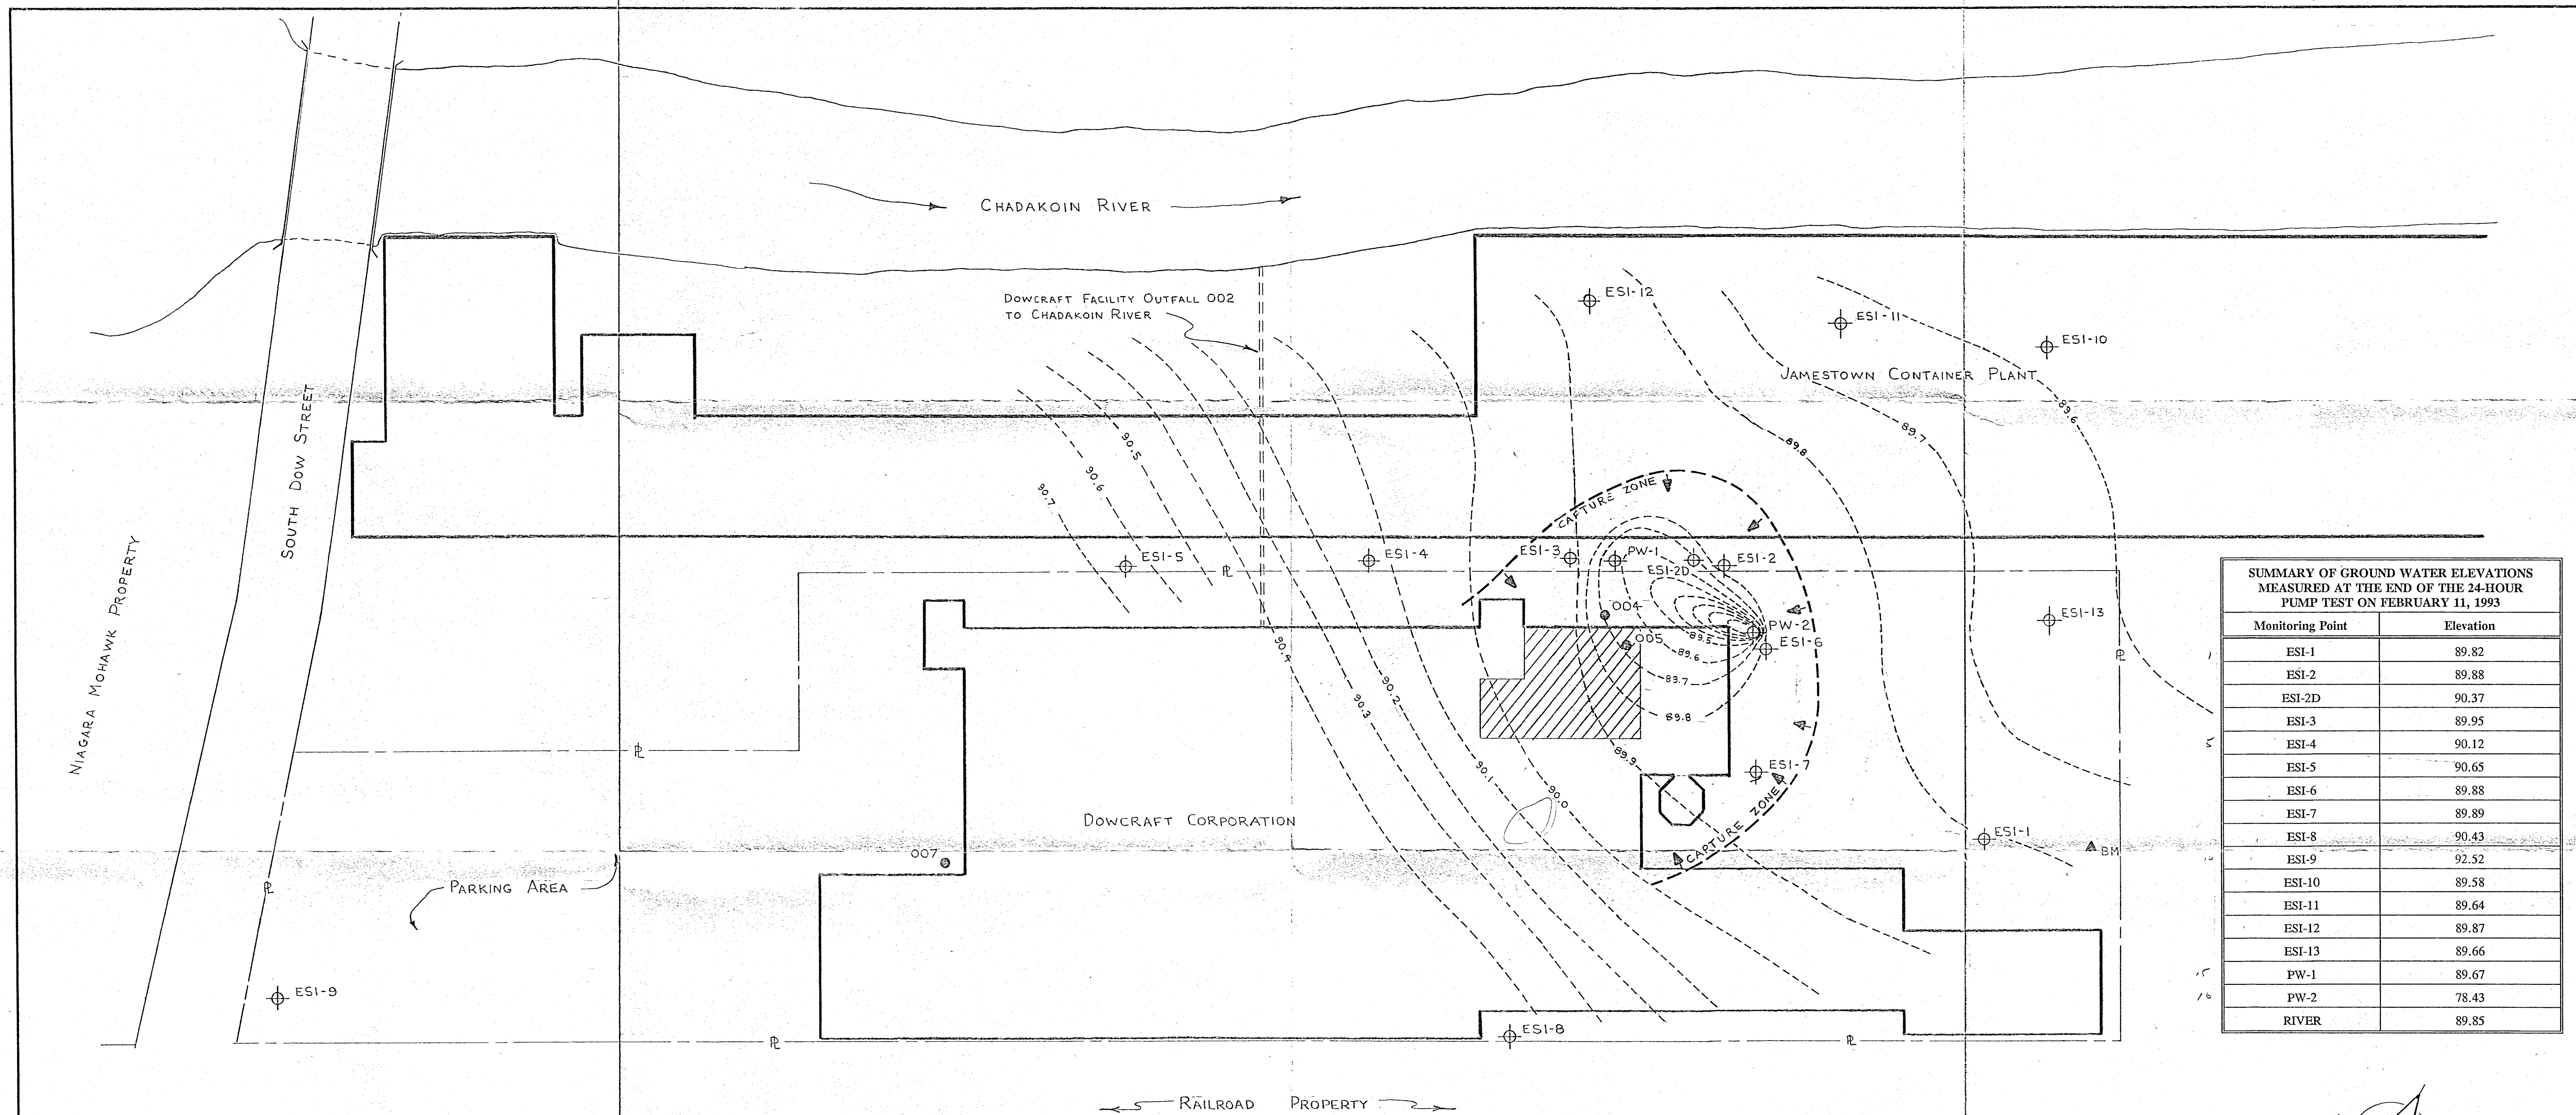


SUMMARY OF GROUND WATER ELEVATIONS MEASURED AT THE END OF THE 24-HOUR PUMP TEST ON FEBRUARY 11, 1993	
Monitoring Point	Elevation
ESI-1	89.82
ESI-2	89.88
ESI-2D	90.37
ESI-3	89.95
ESI-4	90.12
ESI-5	90.65
ESI-6	89.88
ESI-7	89.89
ESI-8	90.43
ESI-9	92.52
ESI-10	89.58
ESI-11	89.64
ESI-12	89.87
ESI-13	89.66
PW-1	89.67
PW-2	78.43
RIVER	89.85

LEGEND:

- ⊕ GROUNDWATER MONITORING WELL LOCATION
- DRYWELL LOCATION
- ▲_{BM} BENCHMARK LOCATION
- AREA USED FOR TRICHLOROETHENE AND SPENT TRICHLOROETHENE STORAGE DURING THE PERIOD BETWEEN 1948 TO 1978.
- GROUND WATER ELEVATION CONTOUR LINE
- CAPTURE ZONE BOUNDARY

NOTES:

- THIS DRAWING IS FOR ILLUSTRATIVE PURPOSES ONLY
- THIS DRAWING WAS ADAPTED FROM A SITE PLAN SUPPLIED BY DOWCRAFT CORPORATION, DATED 3-27-84
- GROUND WATER LEVELS ARE RELATIVE TO A BENCH MARK (▲_{BM}) SET AT AN ARBITRARY ELEVATION OF 100 FT. BENCH MARK IS TOP OF NUT ON WEST SIDE OF FLANGE ON FIRE HYDRANT NORTH OF EAST END OF BUILDING.
- GROUND WATER LEVELS WERE MEASURED ON FEBRUARY 11, 1993 AFTER PUMPING WELL PW-2 AT 20 GPM FOR 24 HOURS

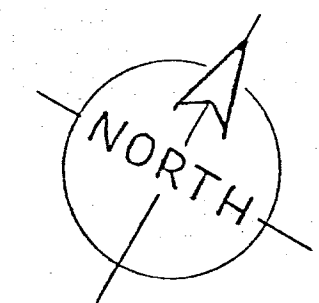

OBSERVED GROUND WATER CAPTURE ZONE (FEBRUARY 11, 1993) Pumping @ PW-2		
SCALE: 1" = 25'	APPROVED BY: KJS	DRAWN BY: DAW
DATE: 4-93		REVISED
DOWCRAFT CORPORATION		
65 SOUTH DOW STREET FALCONER, N.Y. 14733		DRAWING NUMBER 7